



## PERSPECTIVE VIEW

### SHEET LIST

NUMBER	NAME
A-0	COVERSHEET
A-1	FLOOR PLAN
A-2	FLOOR PLAN
A-3	REFLECTED CEILING PLAN
A-4	REFLECTED CEILING PLAN
A-5	ROOF PLAN
A-6	ELEVATION
A-7	ELEVATION
A-8	SECTION
A-9	DOOR & WINDOW SCHEDULE
A-10	CONSTRUCTION DETAILS
A-11	CONSTRUCTION DETAIL
A-12	ELECTRICAL PLAN

No.	Description	Date

 **Unit51Creatives**


**PERSPECTIVE VIEW**

SHEET NO.

**A-0**

Scale:



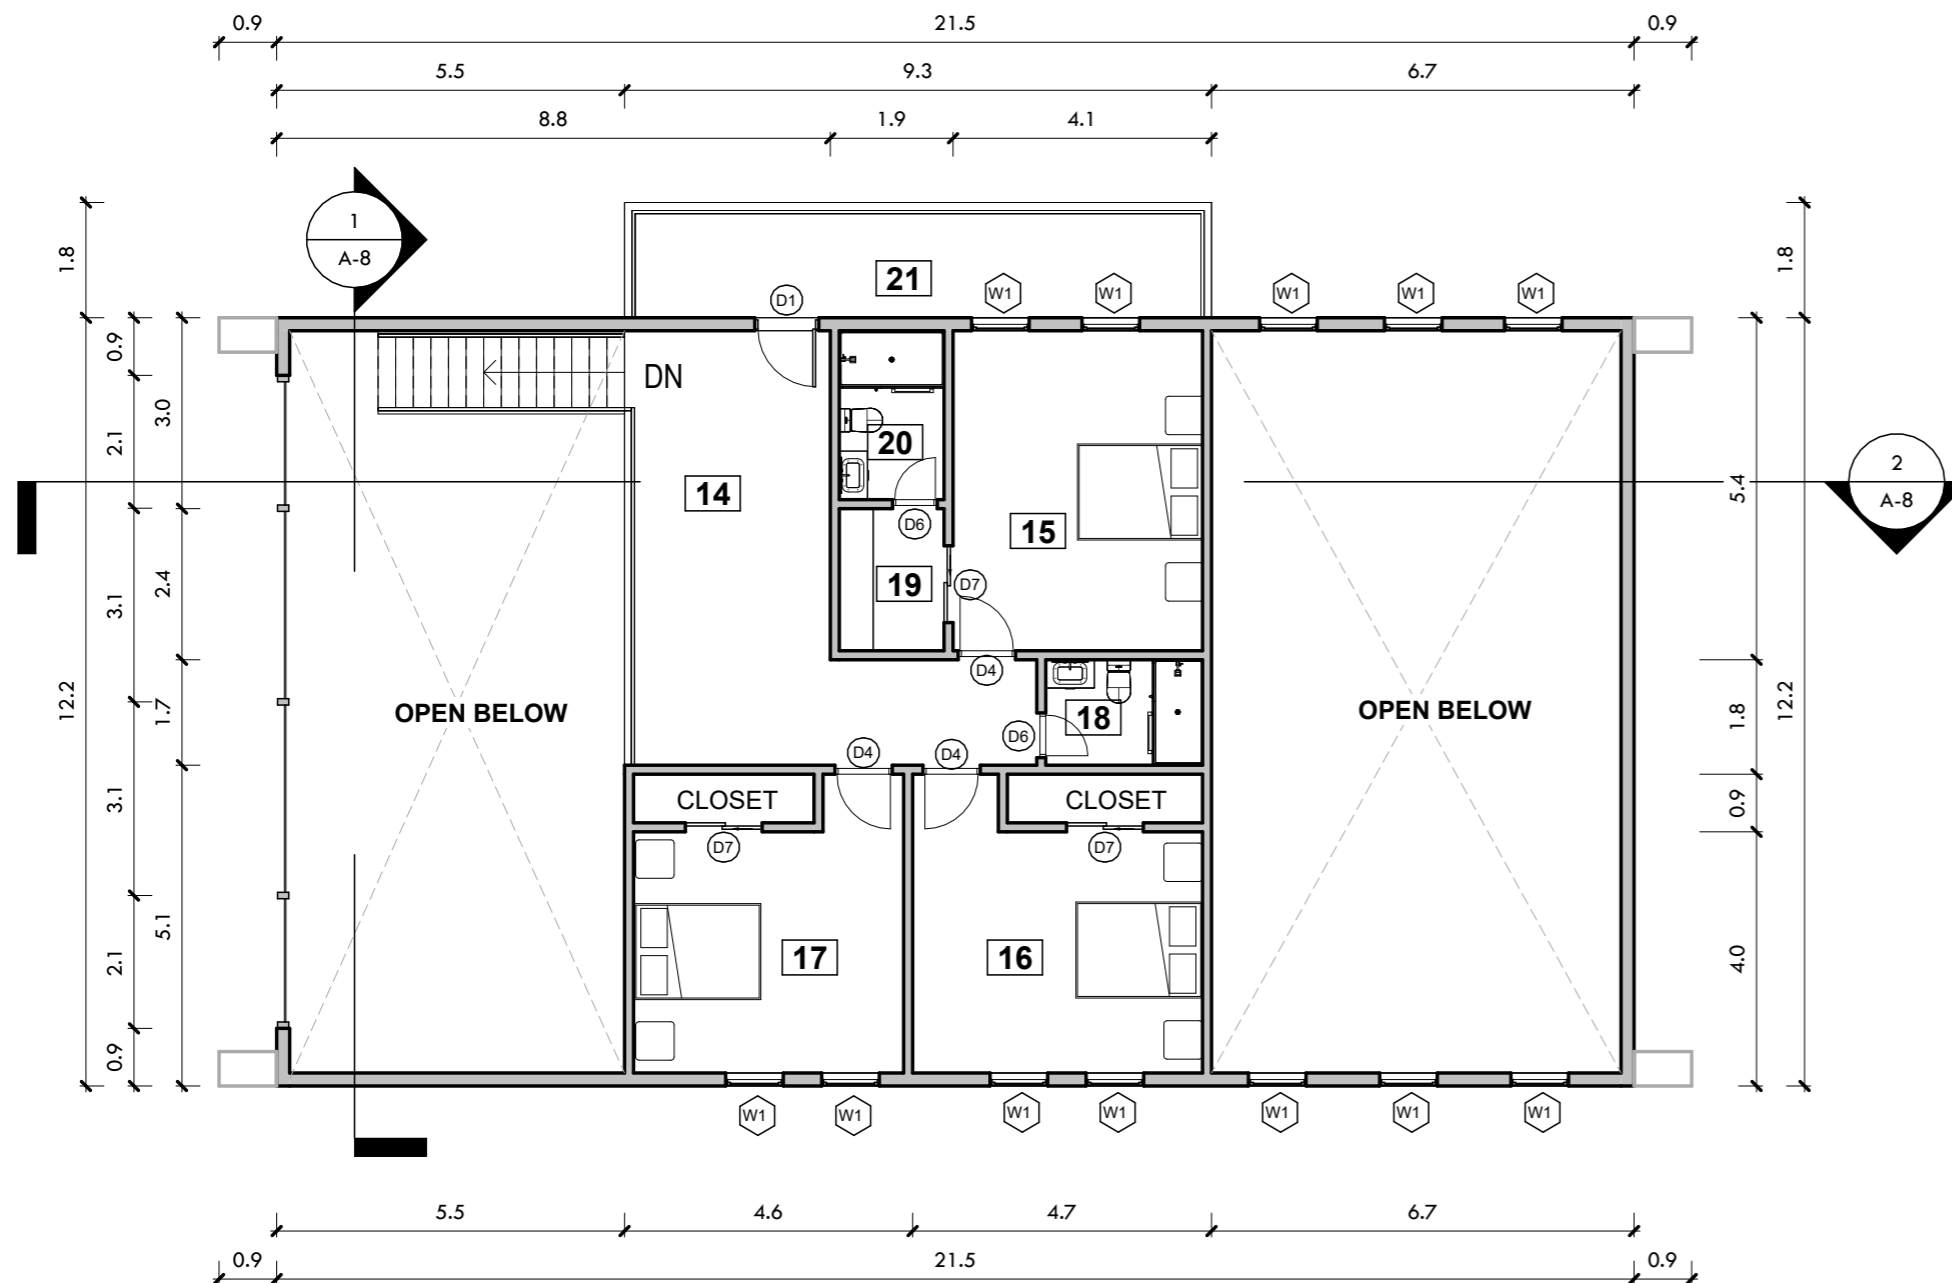

**SECOND FLOOR PLAN**

Scale: 1 : 120

1

**ROOM SCHEDULE**

NUMBER	ROOM NAME	AREA
1	ENTRY	5.4 m <sup>2</sup>
2	LIVING ROOM	35.7 m <sup>2</sup>
3	DINING	35.9 m <sup>2</sup>
4	KITCHEN	15.7 m <sup>2</sup>
5	MASTER BEDROOM	38.5 m <sup>2</sup>
6	WALK-IN CLOSET	4.6 m <sup>2</sup>
7	MASTER BATHROOM	6.2 m <sup>2</sup>
8	HALF BATH	5.7 m <sup>2</sup>
9	LAUNDRY	7.0 m <sup>2</sup>
10	GARAGE	80.0 m <sup>2</sup>
11	CORRIDOR	15.8 m <sup>2</sup>
12	CLOSET	2.4 m <sup>2</sup>
13	PANTRY	2.8 m <sup>2</sup>
14	PLAY ROOM	29.5 m <sup>2</sup>
15	BEDROOM	21.5 m <sup>2</sup>
16	BEDROOM	23.3 m <sup>2</sup>
17	BEDROOM	21.8 m <sup>2</sup>
18	BAHTROOM	4.8 m <sup>2</sup>
19	WALK-IN CLOSET	4.3 m <sup>2</sup>
20	BATHROOM	5.2 m <sup>2</sup>
21	BALCONY	17.0 m <sup>2</sup>

**LEGEND**

- 6 INCH SQUARE LED RECESSED LIGHT
- WALL LAMP
- SMOKE DETECTOR,
- CARBON MONOXIDE ALARM,
- CEILING ENERGY STAR EXHAUST FAN
- DOOR TAG, SEE A5.01.
- WINDOW TAG, SEE A5.01.
- SLOPED GYP.BD CEILING, HEIGHT VARIES
- WATER-RESISTANT GYP.BD CEILING, 10'-0" HIGH FROM FINISH FLOOR
- DUPLEX GROUND FAULT OUTLET
- DUPLEX ELECTRICAL OUTLET
- SWITCH

No.	Description	Date


**Unit51Creatives**

**FLOOR PLAN**

SHEET NO.

**A-2**

Scale: As indicated

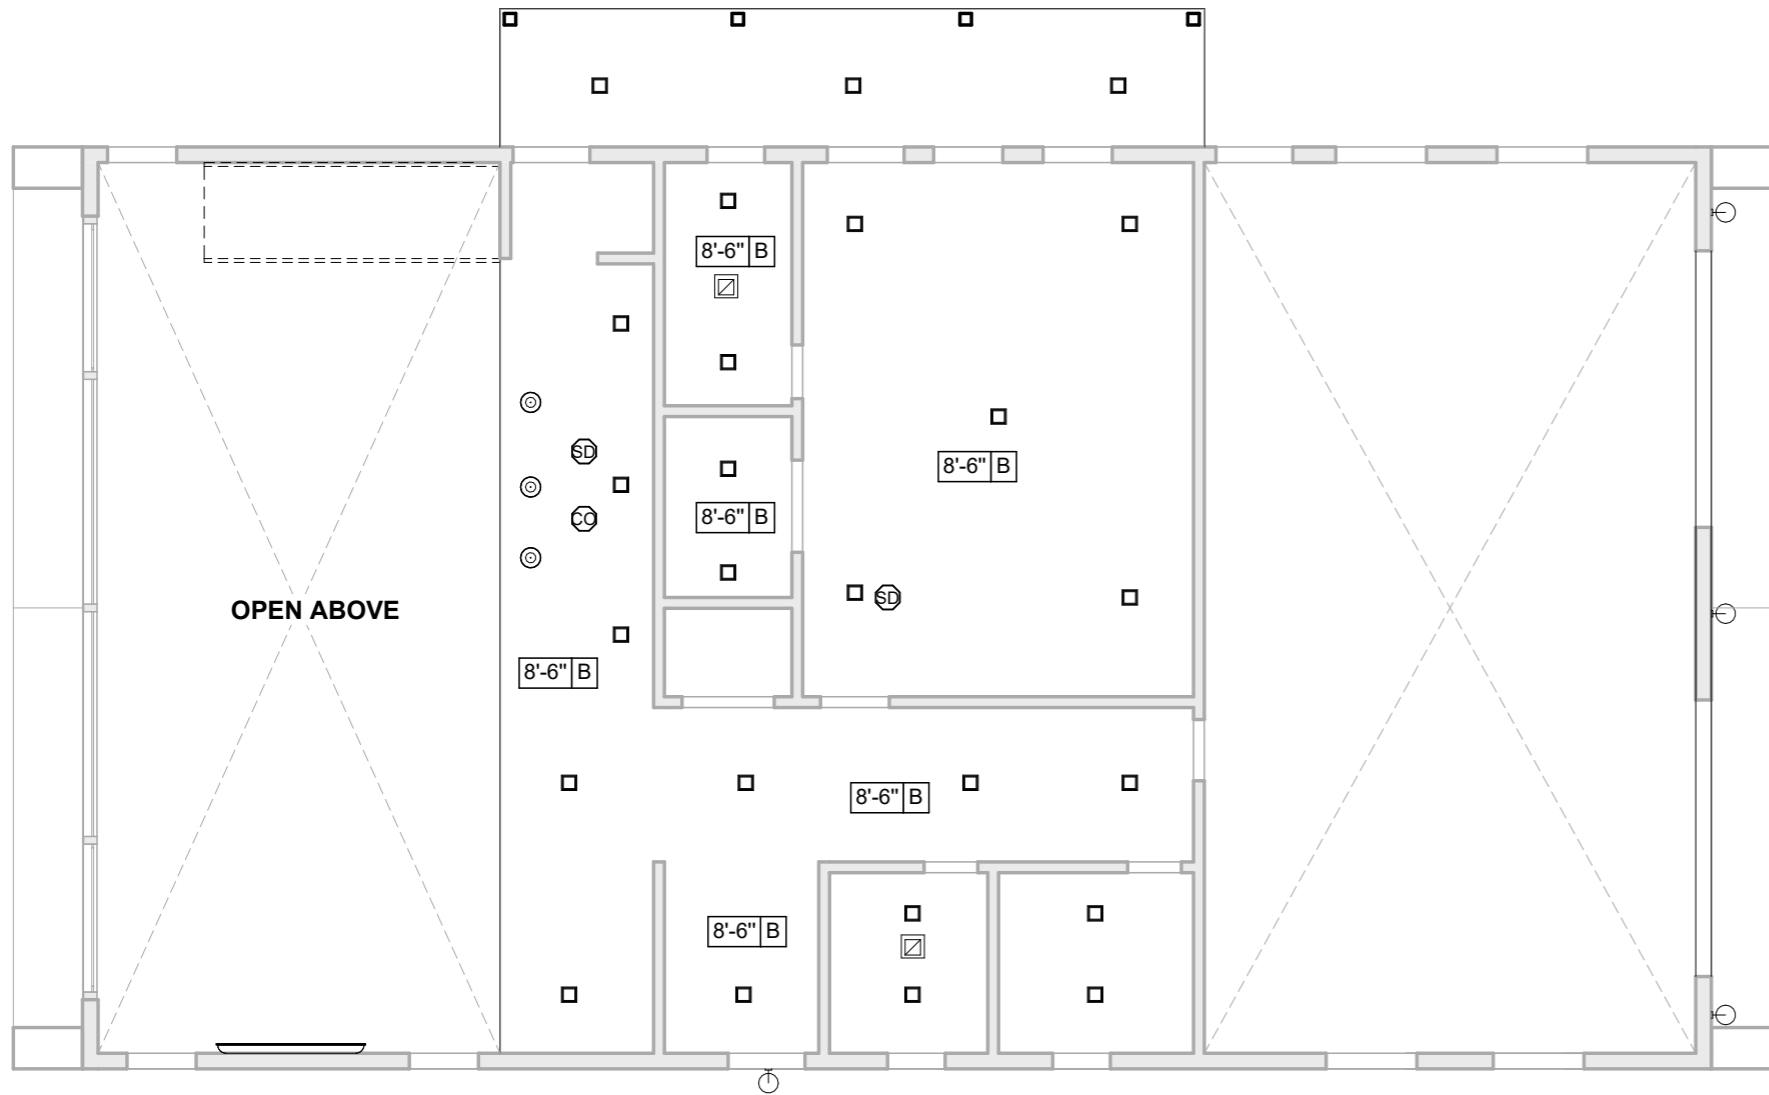

FIRST FLOOR CEILING PLAN

Scale: 1 : 100

1

ROOM SCHEDULE		
NUMBER	ROOM NAME	AREA
1	ENTRY	5.4 m <sup>2</sup>
2	LIVING ROOM	35.7 m <sup>2</sup>
3	DINING	35.9 m <sup>2</sup>
4	KITCHEN	15.7 m <sup>2</sup>
5	MASTER BEDROOM	38.5 m <sup>2</sup>
6	WALK-IN CLOSET	4.6 m <sup>2</sup>
7	MASTER BATHROOM	6.2 m <sup>2</sup>
8	HALF BATH	5.7 m <sup>2</sup>
9	LAUNDRY	7.0 m <sup>2</sup>
10	GARAGE	80.0 m <sup>2</sup>
11	CORRIDOR	15.8 m <sup>2</sup>
12	CLOSET	2.4 m <sup>2</sup>
13	PANTRY	2.8 m <sup>2</sup>
14	PLAY ROOM	29.5 m <sup>2</sup>
15	BEDROOM	21.5 m <sup>2</sup>
16	BEDROOM	23.3 m <sup>2</sup>
17	BEDROOM	21.8 m <sup>2</sup>
18	BAHTROOM	4.8 m <sup>2</sup>
19	WALK-IN CLOSET	4.3 m <sup>2</sup>
20	BATHROOM	5.2 m <sup>2</sup>
21	BALCONY	17.0 m <sup>2</sup>

LEGEND

- 6 INCH SQUARE LED RECESSED LIGHT
- WALL LAMP
- SMOKE DETECTOR,
- CARBON MONOXIDE ALARM,
- CEILING ENERGY STAR EXHAUST FAN
- DOOR TAG, SEE A5.01.
- WINDOW TAG, SEE A5.01.
- SLOPED GYP.BD CEILING, HEIGHT VARIES
- WATER-RESISTANT GYP.BD CEILING, 10'-0" HIGH FROM FINISH FLOOR
- DUPLEX GROUND FAULT OUTLET
- DUPLEX ELECTRICAL OUTLET
- SWITCH

No.	Description	Date

**Unit51Creatives**

**REFLECTED  
CEILING PLAN**

SHEET NO.

A-3

Scale: As indicated







 
 
 
 
 



SECOND FLOOR CEILING PLAN

Scale: 1 : 100

1

ROOM SCHEDULE		
NUMBER	ROOM NAME	AREA
1	ENTRY	5.4 m <sup>2</sup>
2	LIVING ROOM	35.7 m <sup>2</sup>
3	DINING	35.9 m <sup>2</sup>
4	KITCHEN	15.7 m <sup>2</sup>
5	MASTER BEDROOM	38.5 m <sup>2</sup>
6	WALK-IN CLOSET	4.6 m <sup>2</sup>
7	MASTER BATHROOM	6.2 m <sup>2</sup>
8	HALF BATH	5.7 m <sup>2</sup>
9	LAUNDRY	7.0 m <sup>2</sup>
10	GARAGE	80.0 m <sup>2</sup>
11	CORRIDOR	15.8 m <sup>2</sup>
12	CLOSET	2.4 m <sup>2</sup>
13	PANTRY	2.8 m <sup>2</sup>
14	PLAY ROOM	29.5 m <sup>2</sup>
15	BEDROOM	21.5 m <sup>2</sup>
16	BEDROOM	23.3 m <sup>2</sup>
17	BEDROOM	21.8 m <sup>2</sup>
18	BAHTROOM	4.8 m <sup>2</sup>
19	WALK-IN CLOSET	4.3 m <sup>2</sup>
20	BATHROOM	5.2 m <sup>2</sup>
21	BALCONY	17.0 m <sup>2</sup>

LEGEND

-  6 INCH SQUARE LED RECESSED LIGHT
-  WALL LAMP
-  SMOKE DETECTOR,
-  CARBON MONOXIDE ALARM,
-  CEILING ENERGY STAR EXHAUST FAN
-  DOOR TAG, SEE A5.01.
-  WINDOW TAG, SEE A5.01.
-  SLOPED GYP.BD CEILING, HEIGHT VARIES
-  WATER-RESISTANT GYP.BD CEILING, 10'-0" HIGH FROM FINISH FLOOR
-  DUPLEX GROUND FAULT OUTLET
-  DUPLEX ELECTRICAL OUTLET
-  SWITCH

No.	Description	Date

**Unit51Creatives**




**REFLECTED  
CEILING PLAN**

SHEET NO.

**A-4**

Scale: As indicated



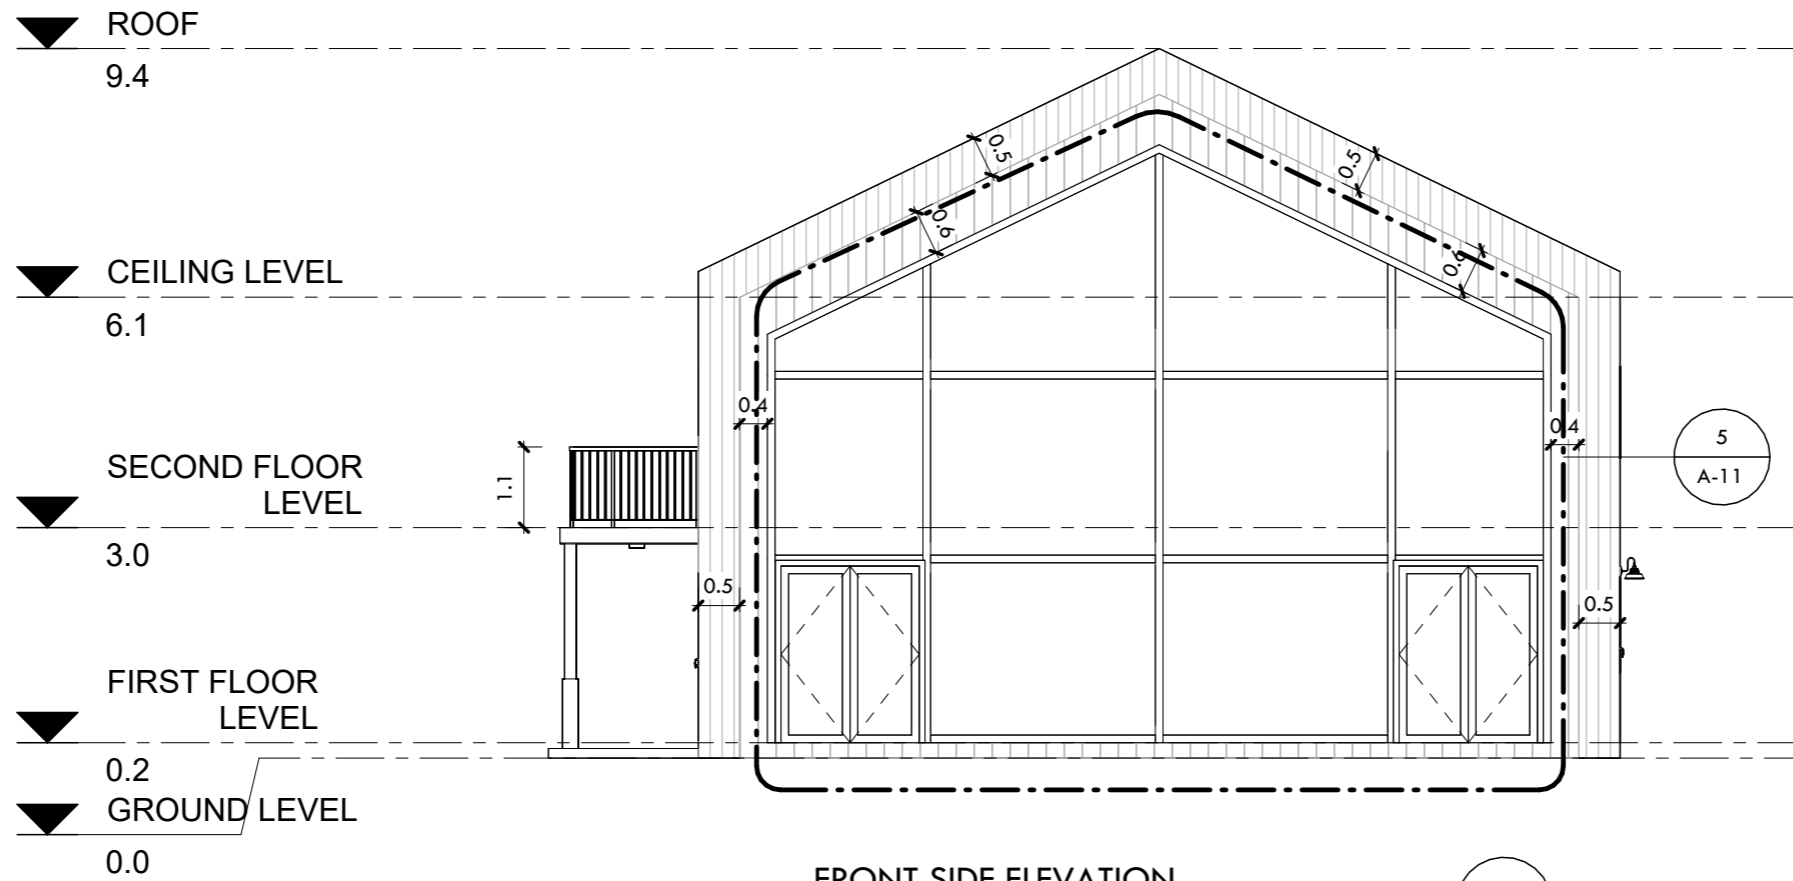

FRONT SIDE ELEVATION  
Scale: 1 : 100




RIGHT ELEVATION  
Scale: 1 : 100

No.	Description	Date

**Unit51Creatives**


# ELEVATION

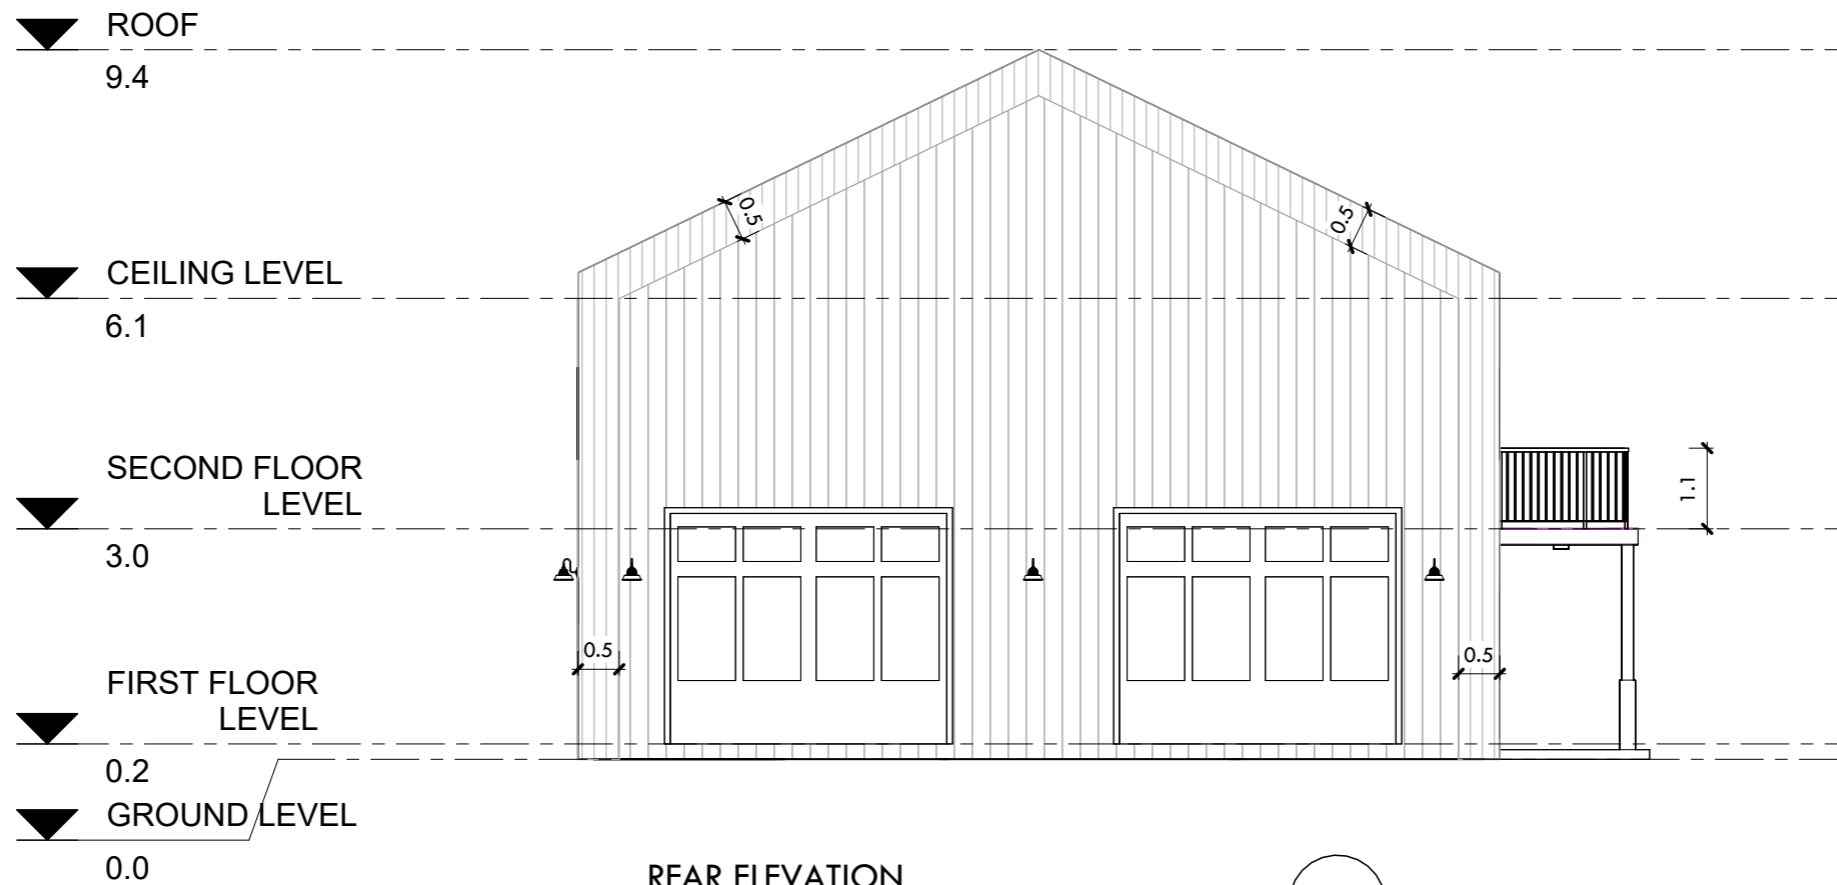

REAR ELEVATION

Scale: 1 : 100

2

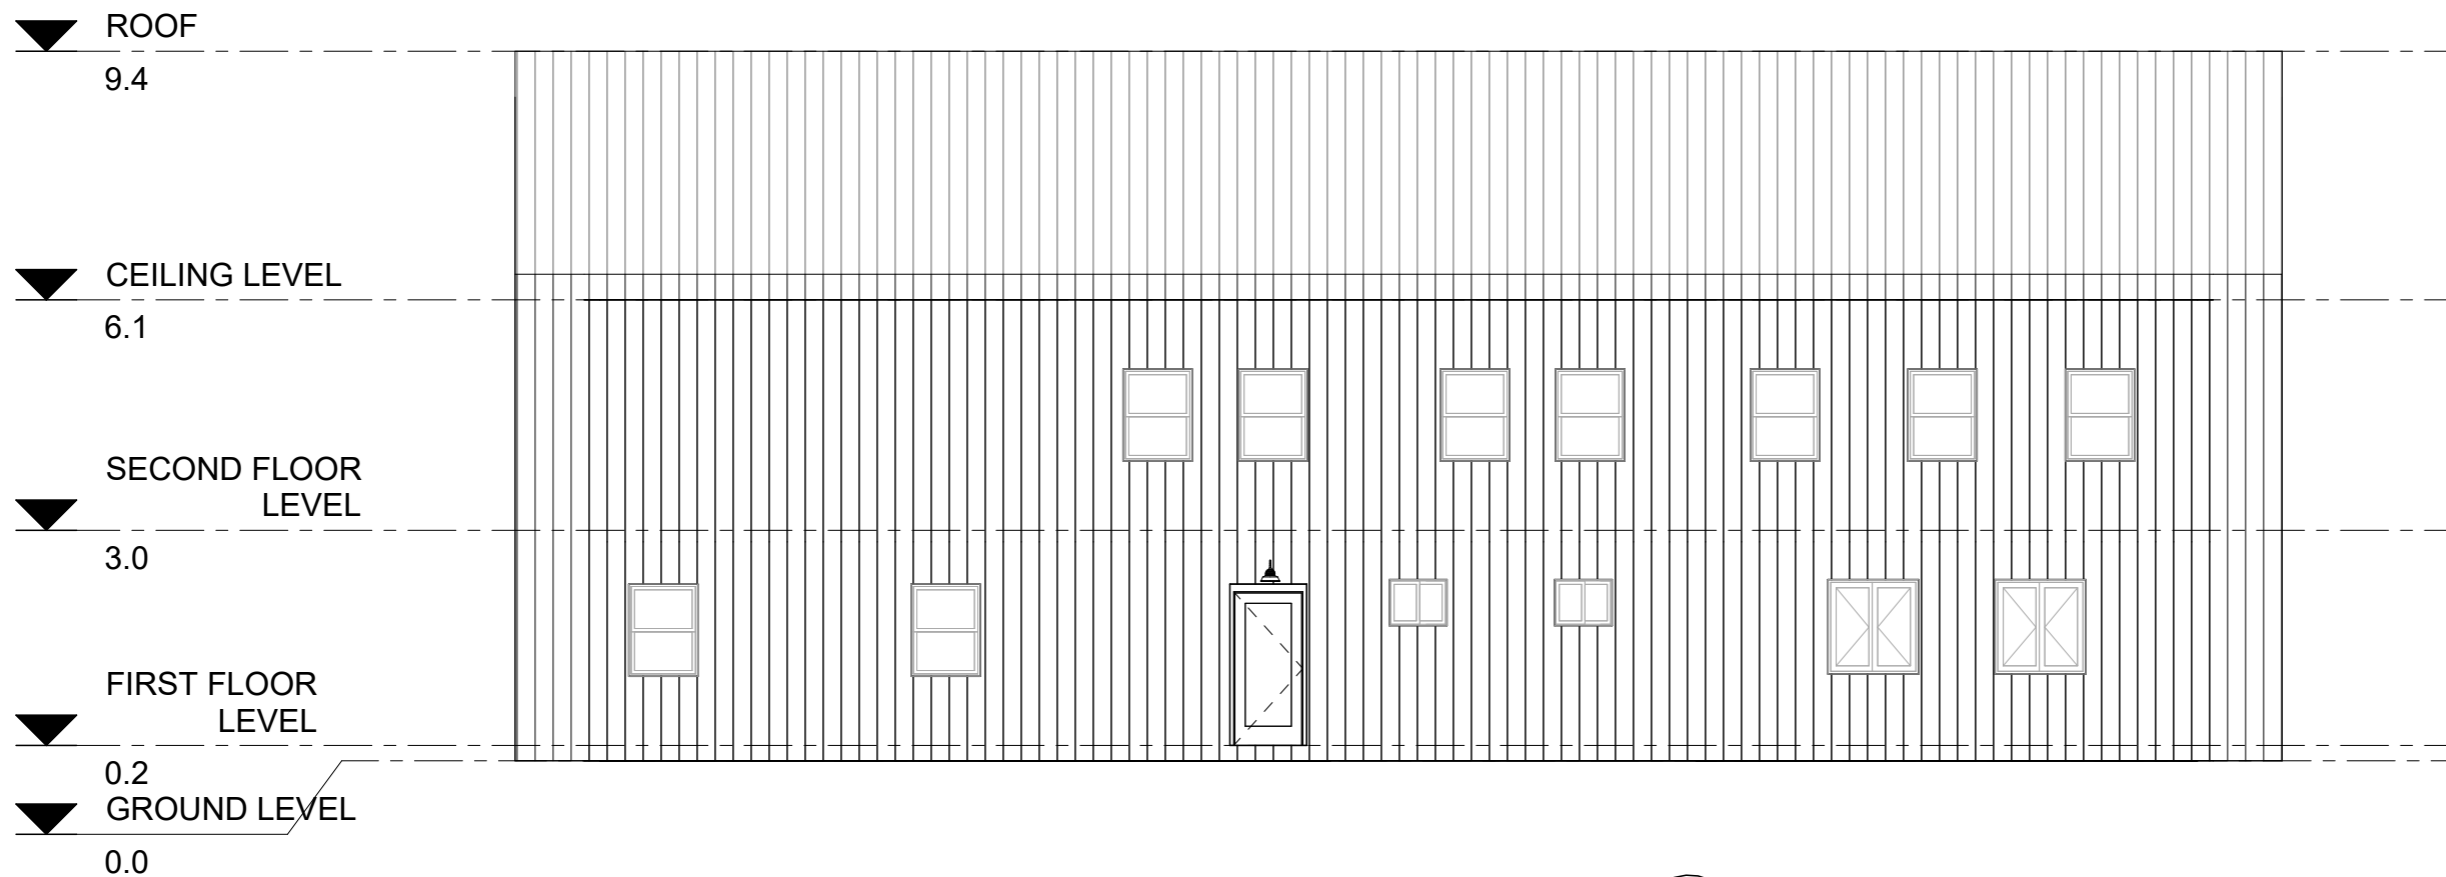

LEFT ELEVATION

Scale: 1 : 100


1

No.	Description	Date

 **Unit51Creatives**


**ELEVATION**

SHEET NO.  
**A-7**  
Scale: 1 : 100

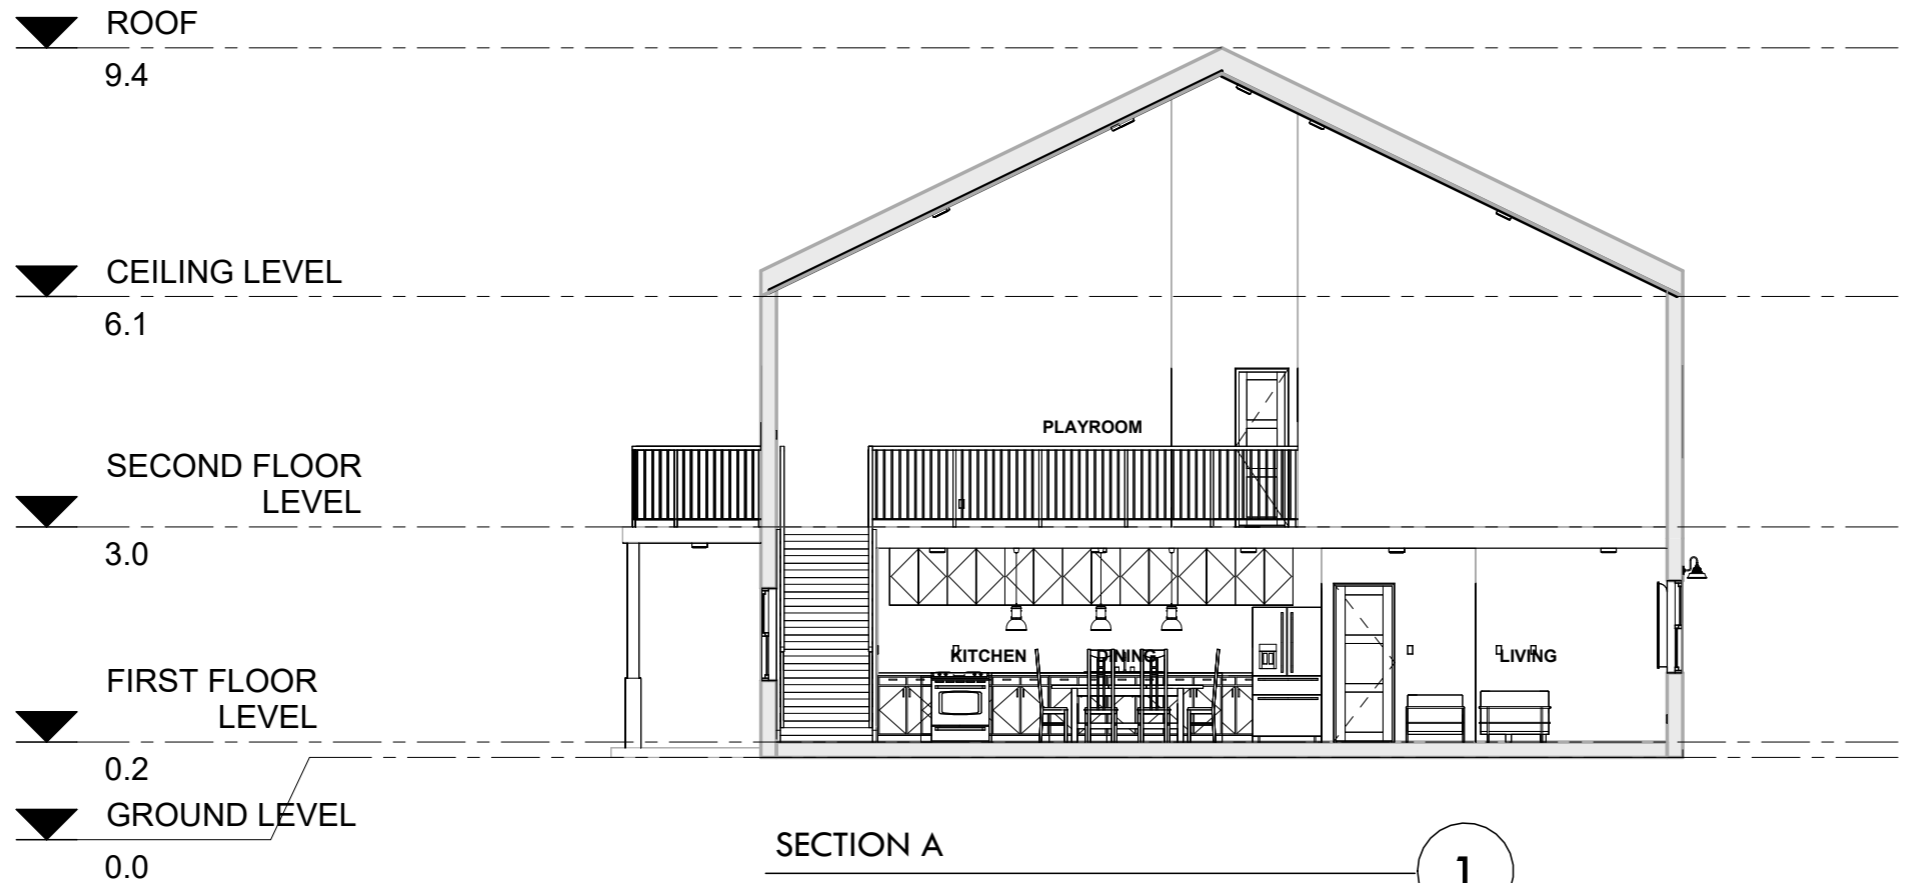

SECTION A  
Scale: 1 : 100

1

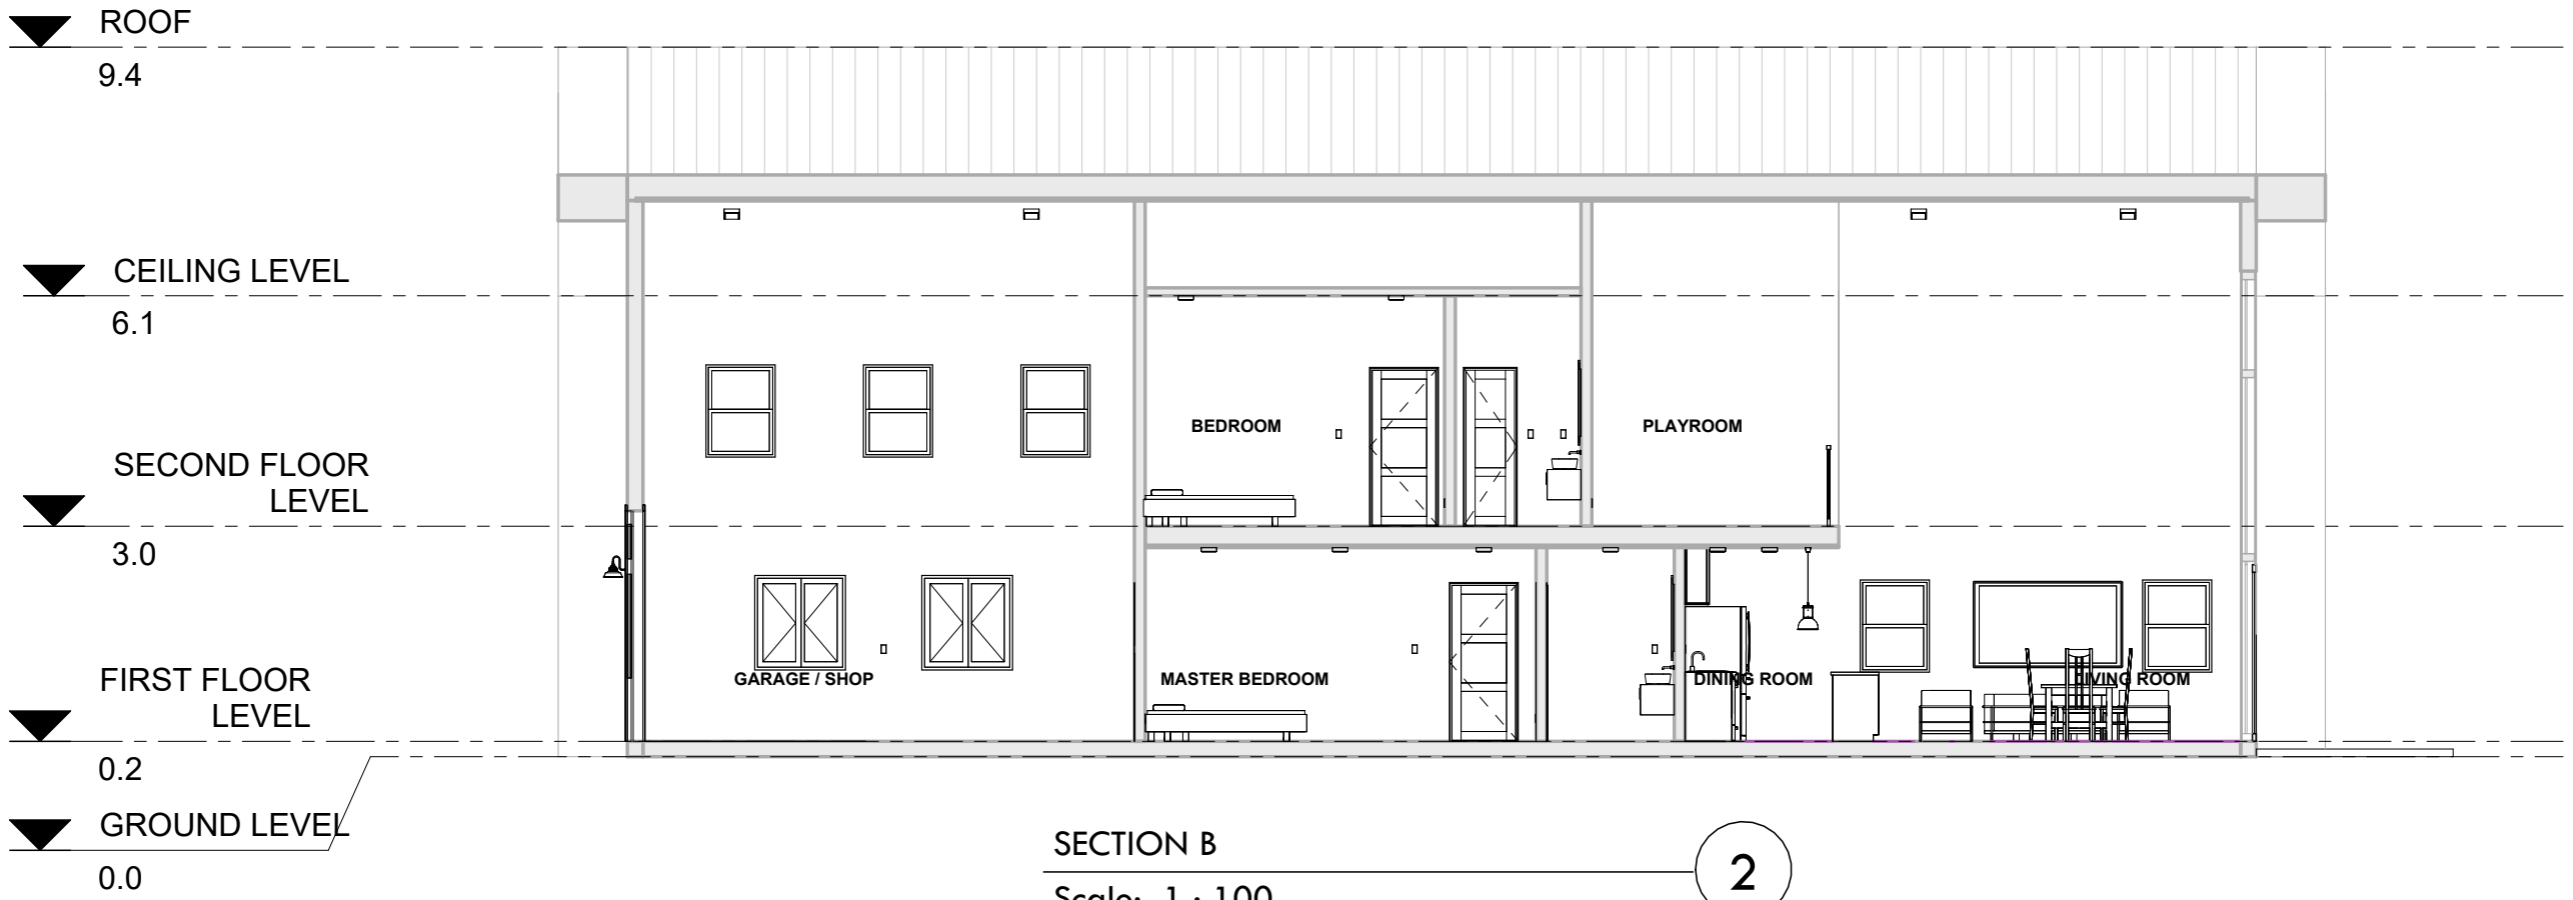

SECTION B  
Scale: 1 : 100

2

No.	Description	Date

**Unit51Creatives**



**SECTION**


SHEET NO.

**A-8**


Scale: 1 : 100

DOOR SCHEDULE			
DOOR	Count	DOOR	
		WIDTH	HEIGHT
D1	4	0.9	2.0
D2	1	0.9	2.0
D3	2	1.8	2.3
D4	4	0.9	2.1
D5	1	0.8	2.1
D6	5	0.7	2.1
D7	5	1.2	2.0
D9	2	3.7	3.0


Grand total: 24

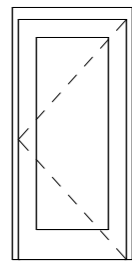


**D2**  
PANEL DOOR

 


**D2-D5**  
SINGLE PANEL DOOR

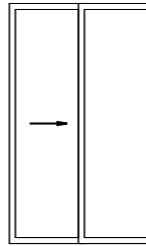

**D5**  
DOUBLE SLIDING DOOR

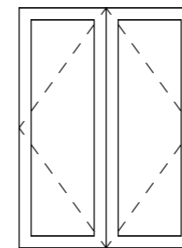


**D6**  
FOUR PANEL SLIDING DOOR

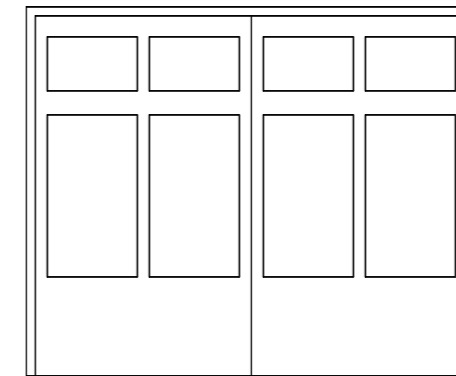


**D7**  
FOUR PANEL SLIDING DOOR

WINDOW SCHEDULE			
WINDOW	Count	Width	Height
W1	17	0.9	1.2
W2	4	1.2	1.3
W3	3	0.8	0.6

 
Grand total: 24



**W1**  
DOUBLE HUNG  
WINDOW

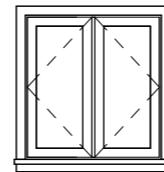

**W2**  
CASEMENT WINDOW

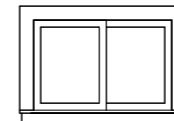

**W3**  
SLIDING WINDOW

# DOOR & WINDOW SCHEDULE

No.	Description	Date


**Unit51Creatives**

# DOOR & WINDOW SCHEDULE

SHEET NO.

A-9

Scale: As indicated

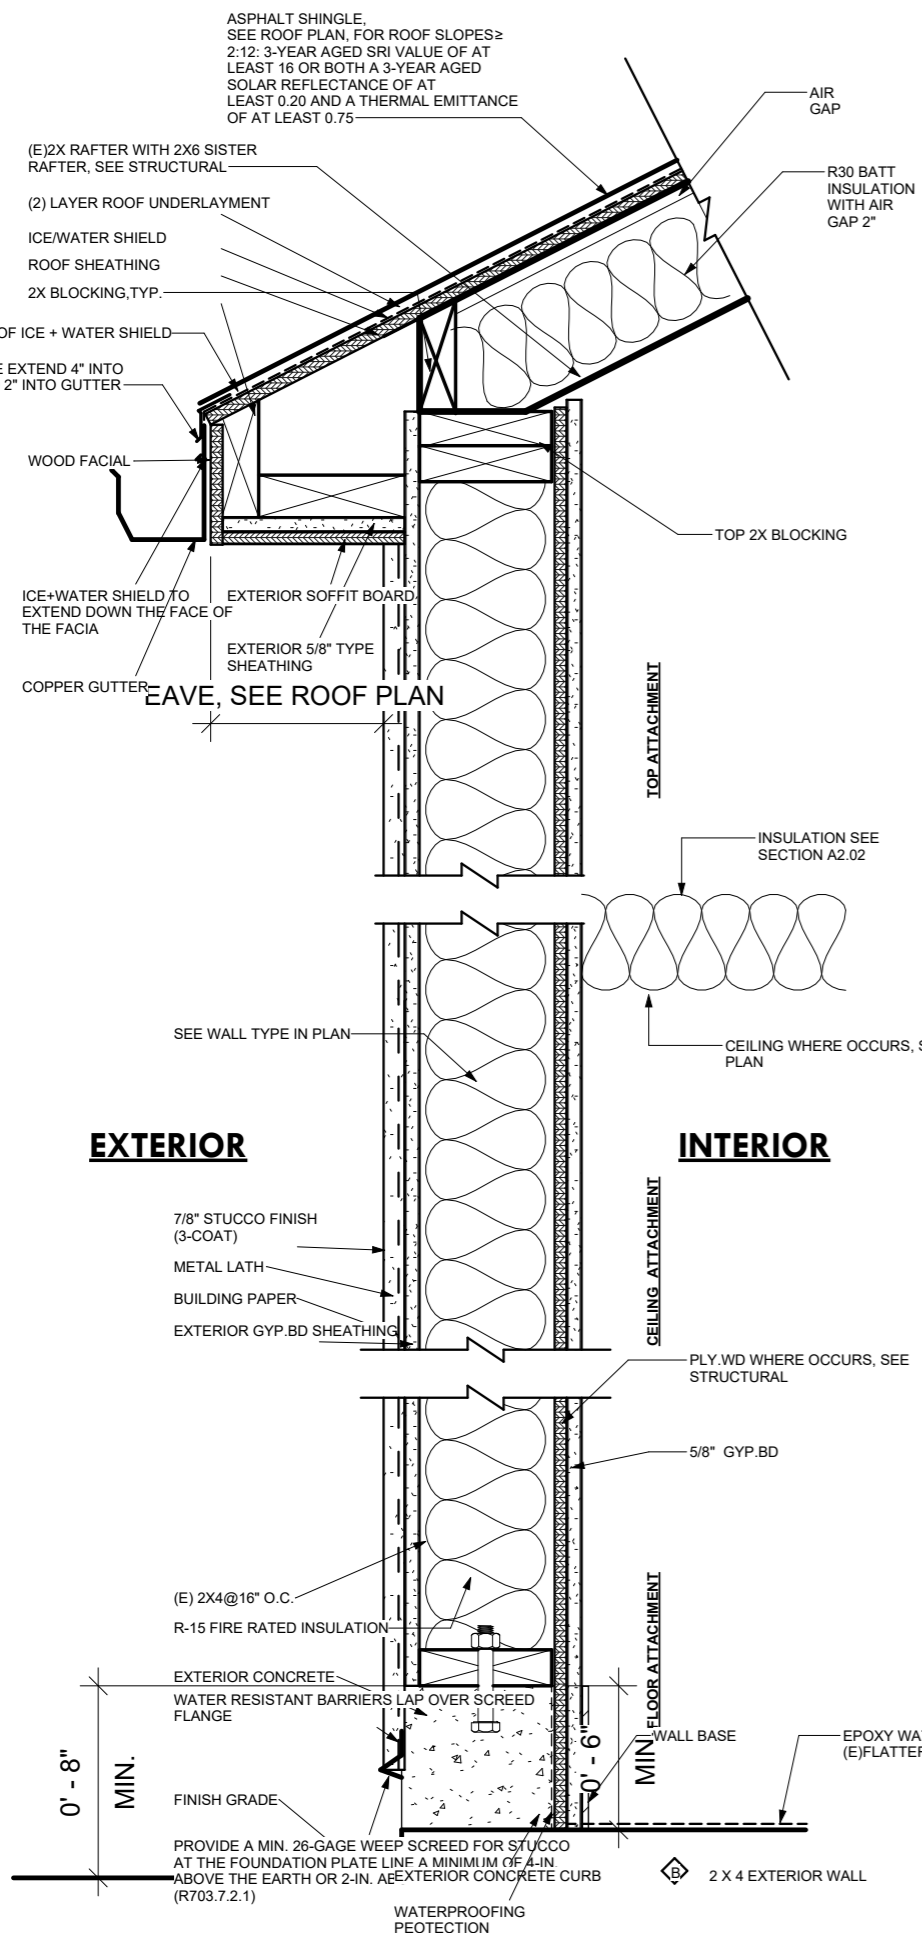


**EXTERIOR**

**INTERIOR**

**EXTERIOR WALL SECTION WITH EAVE**

Scale: 1 : 8


7

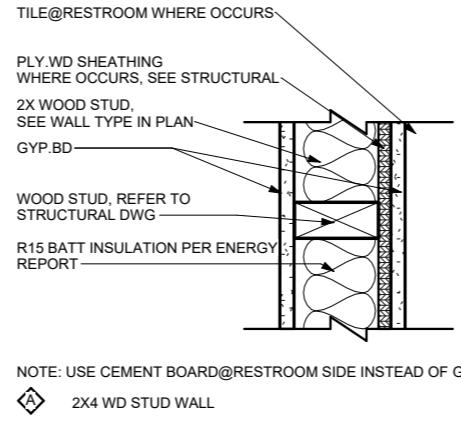

**INTERIOR WALL**

Scale: 1 : 8


6

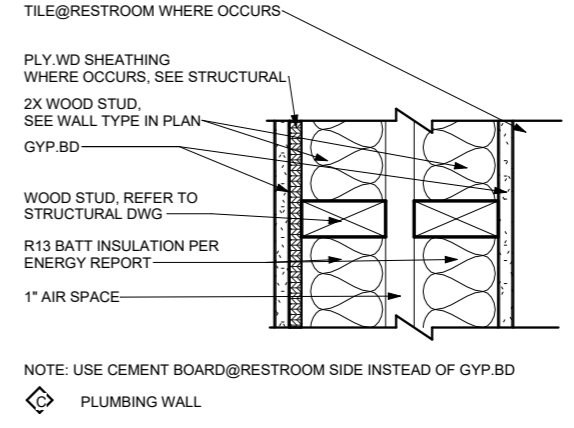

**INTERIOR PLUMBING WALL**

Scale: 1 : 8


1

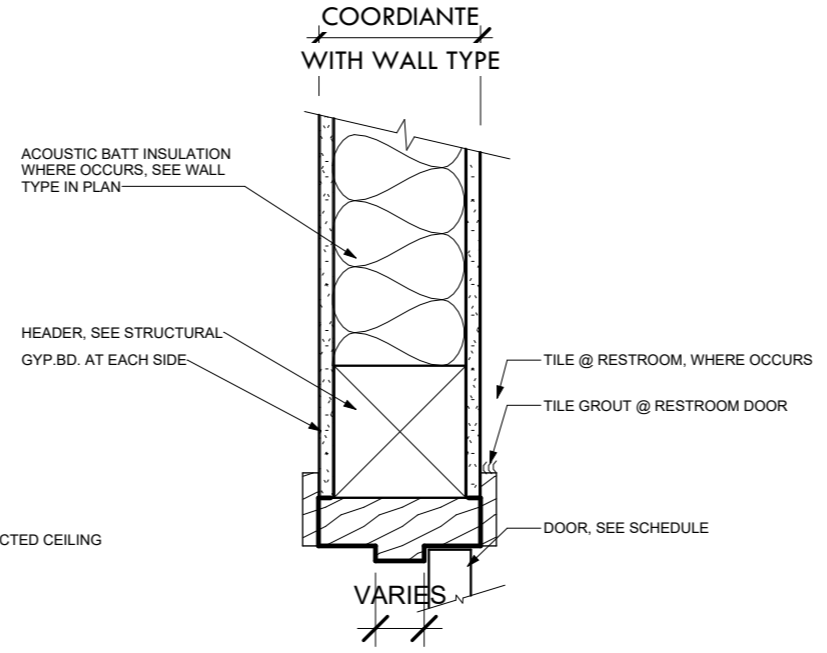

**INTERIOR DOOR HEADER @ WOOD STUD**

Scale: 1 : 8


4

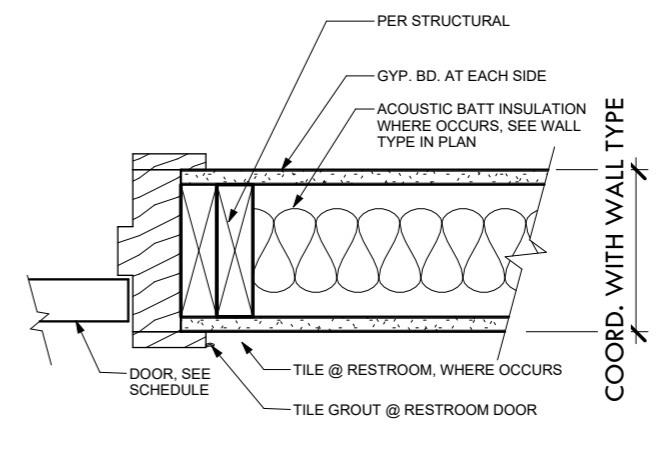

**INTERIOR DOOR JAMB @ WOOD STUD**

Scale: 1 : 8


5

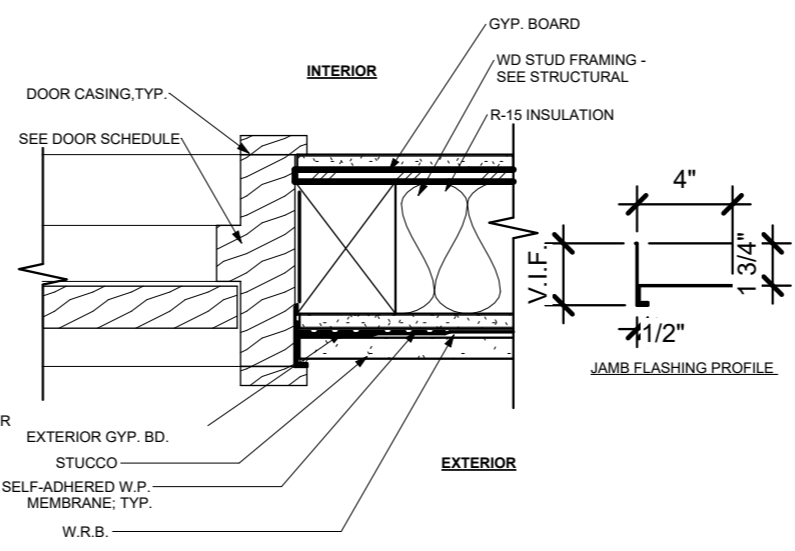

**EXTERIOR DOOR JAMB\_STUCCO**

Scale: 1 : 8

2

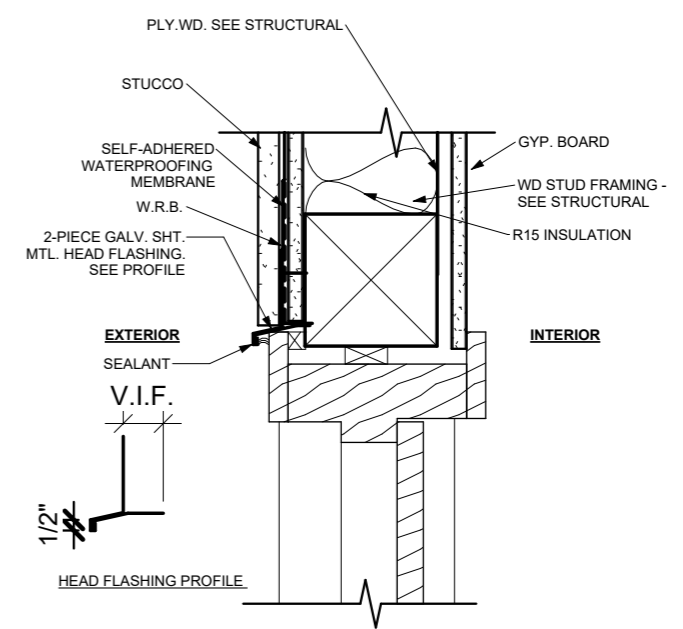

**EXTERIOR DOOR HEAD\_STUCCO**

Scale: 1 : 8

3

No.	Description	Date

**Unit51Creatives**


**CONSTRUCTION DETAIL**

SHEET NO.

**A-10**

Scale: 1 : 8




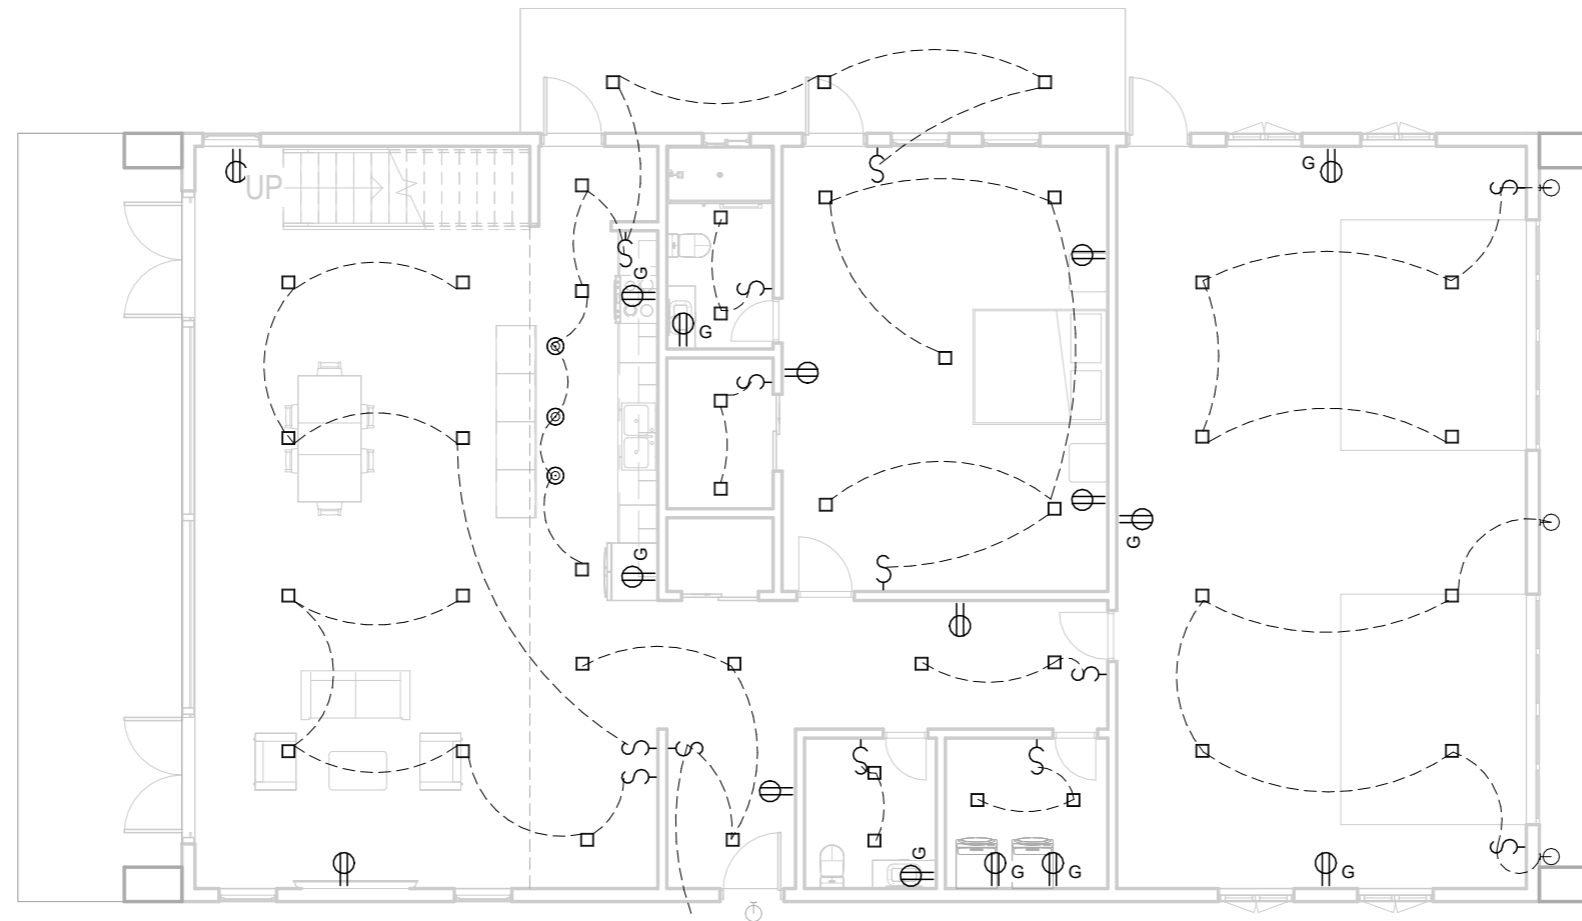

FIRST FLOOR ELECTRICAL PLAN

Scale: 1 : 120

1

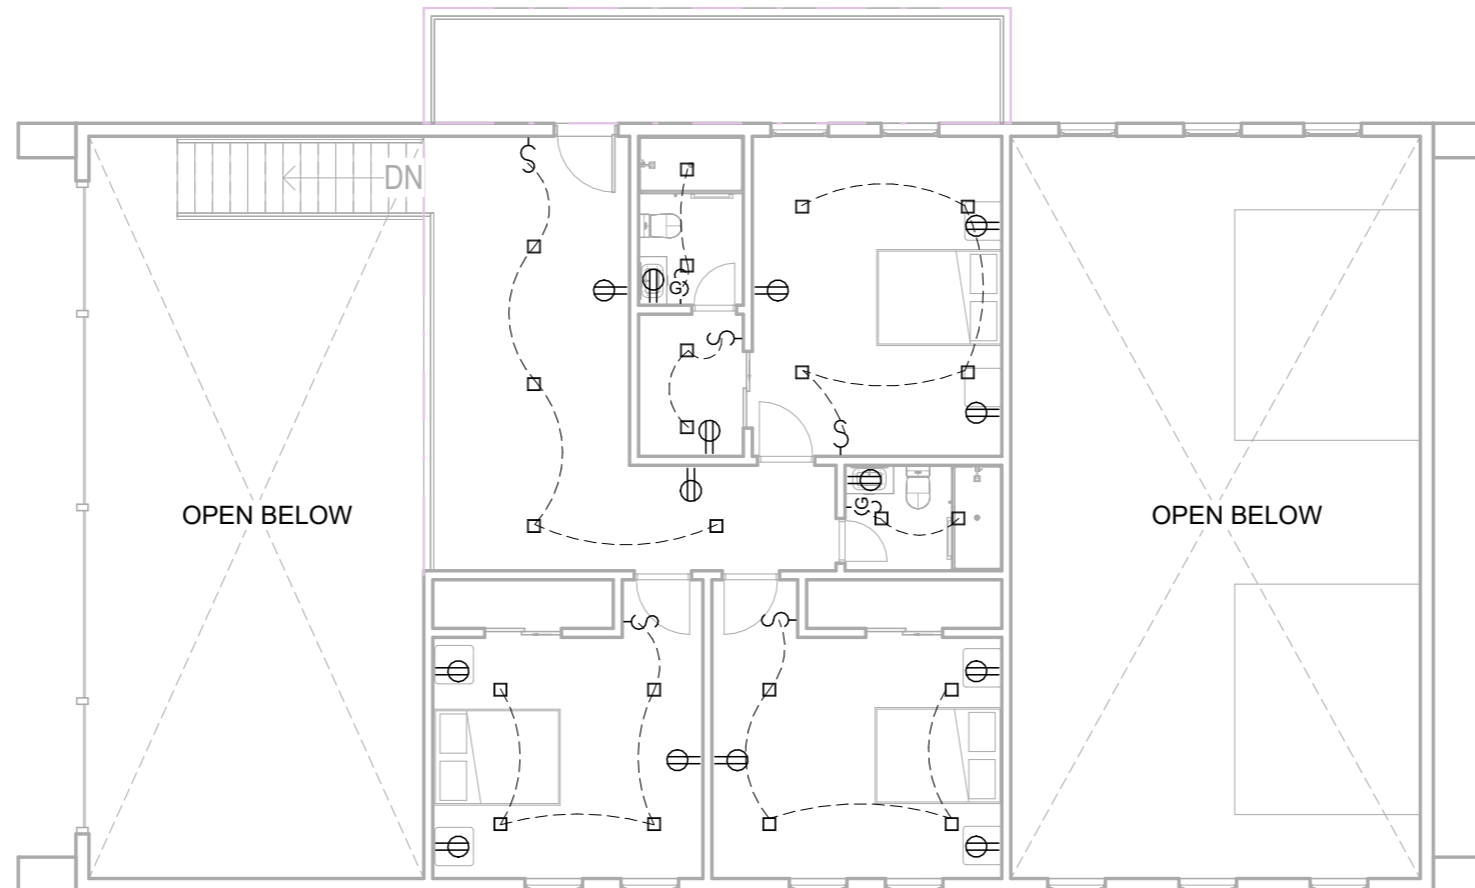


LOFT ELECTRICAL PLAN

Scale: 1 : 120

2

No.	Description	Date

 **Unit51Creatives**

# ELECTRICAL PLAN

SHEET NO.

**A-12**

Scale: 1 : 120